


BUILDING KEY

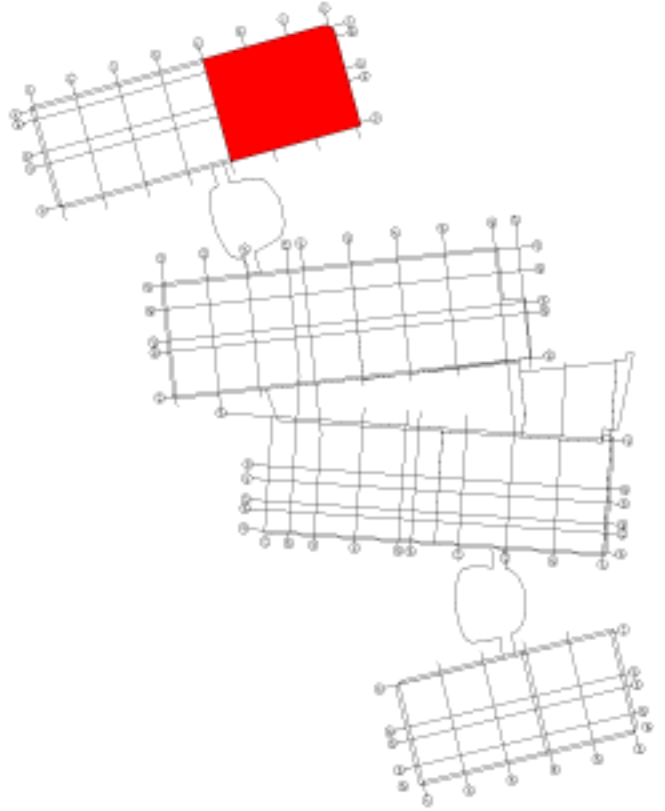

NOTES

1. DO NOT SCALE
2. THIS DRAWING IS TO BE READ IN CONJUNCTION WITH ALL OTHER ARCHITECTS, STRUCTURAL ENGINEERS AND BUILDING SERVICES ENGINEERS DRAWINGS, SPECIFICATIONS AND SCHEDULES
3. ALL DIMENSIONS IN MILLIMETERS

COMMENT STATUS

A	B	C
---	---	---

P3	ISSUED FOR STAGE E	23/01/2012	PB
P2	ISSUED FOR STAGE E	21/12/2011	PB
P1	ISSUED FOR STAGE E	14/10/2011	PB
REV	DESCRIPTION	DATE	BY

Client

Project

Title
Building 1
Ventilation Layout
Level L04
Sheet 2 of 2

Discipline
MECHANICAL SERVICES
Status
DESIGN DEVELOPMENT

Drawn by KW	Checked by ED	Size A1
Job No. G00054	Scale 1 : 50	Date 27/01/2012

REV
P3

