



General Notes

Rev. Description Author Date

ARCHITECT

PROJECT

ADDRESS

CLIENT

ARCHITECT

ELECTRICAL DRAWING


TYPE : Ground Floor Electrical

DRAWING NO. E-01

SCALE 1:100

DATE

PROJECT NO. 018

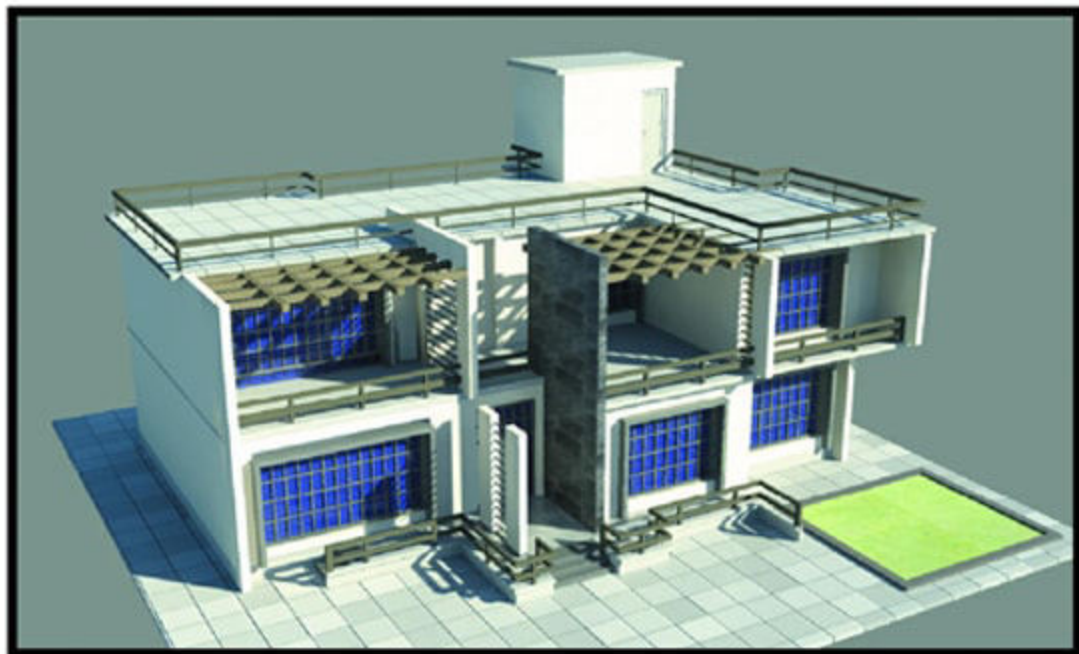

Sectional Analysis

Ido	Idoqwaqwaqwaqwaqwa	Ido

TRACT	
PROJECT	
ADDRESS	
CLIENT	
ARCHITECT	

ELECTRICAL DRAWING	
FILE: Ground Floor Electrical	
DRAWING NO:	E-01
SCALE:	1:100
DRAWN BY:	
DATE:	
SHEET NO:	01/1



Ground Floor Plan

NO.	Revisions/Notes	Date
-----	-----------------	------

CONTRACT	
PROJECT	
ADDRESS	
CLIENT	
ARCHITECT	

ELECTRICAL DRAWING

TITLE :	Ground Floor Electrical
DRAWING NO.	E-01
SCALE	1:100
DRAWN BY	
CHECKED BY	
DATE	01/01/2023



General Notes

Rev.	Description/Notes	Date

TRACT	BH-C013.A
PROJECT	
ADDRESS	
CLIENT	
ARCHITECT	

ELECTRICAL DRAWING	
TITLE: Ground Floor Electrical	E-01
DRAWING NO:	1:100
SCALE	
DATE	
SHEET NO	018



General Notes

Rev.	Description	Date

ARCHIT	
PROJECT	
WORKERS	
CLIENT	
ARCHITECT	

ELECTRICAL DRAWING

TITLE	Ground Floor Electrical	
DRAWING NO.	E-01	
SCALE	1:100	
DRAWN BY		
DATE		
CHECKED BY		



